
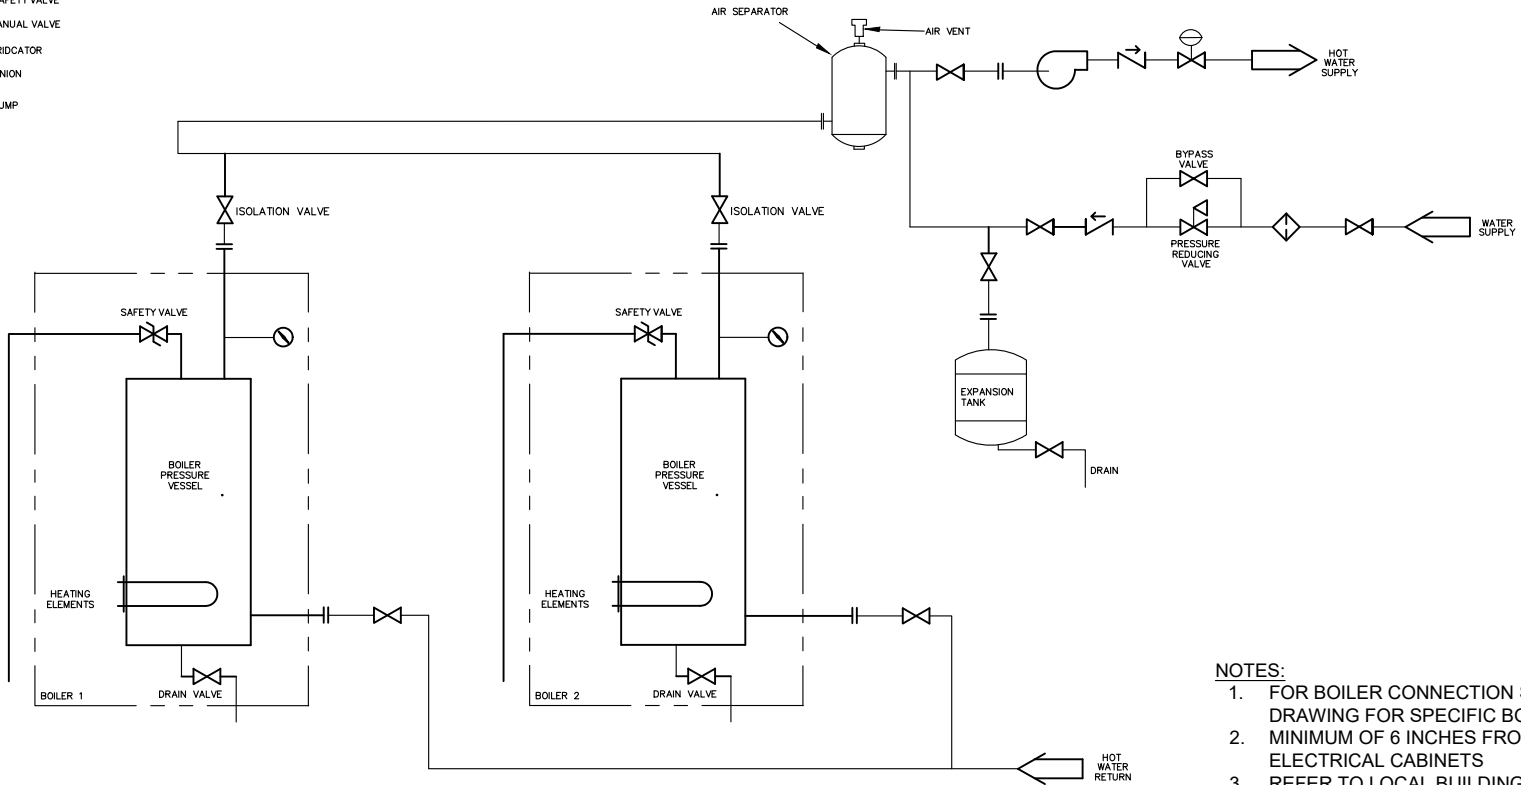


4

3

2

1

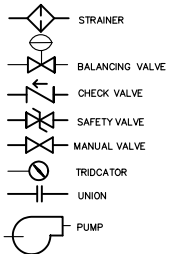

- NOTES:**
1. FOR BOILER CONNECTION SIZES SEE DIMENSIONAL DRAWING FOR SPECIFIC BOILER CONFIGURATION
 2. MINIMUM OF 6 INCHES FROM BOILER CONNECTIONS AND ELECTRICAL CABINETS
 3. REFER TO LOCAL BUILDING CODE TO MAKE SURE SYSTEM CONFORMS WITH LOCAL POLICIES



TITLE				
P&ID - EW HOT WATER BOILER PRIMARY MULTIPLE UNITS				
NAME	DATE	DWG#	REV	
DRAWN BY	SC	5/17/24	EW-P&ID-PRIMULTI	A/1
CHECKED BY			SHEET 1 OF 1	

A/1		PRINT REVIEW	SC	5/17/24
REV	ECN	REVISION DESCRIPTION	NAME	DATE

4

3

2

1